 



⌈ ⌋	HOT AND COLD WATER
⌈ ⌋	DOOR BELL
⌈ ⌋	MOTION DETECTOR LIGHT (DECK RM JOIST)

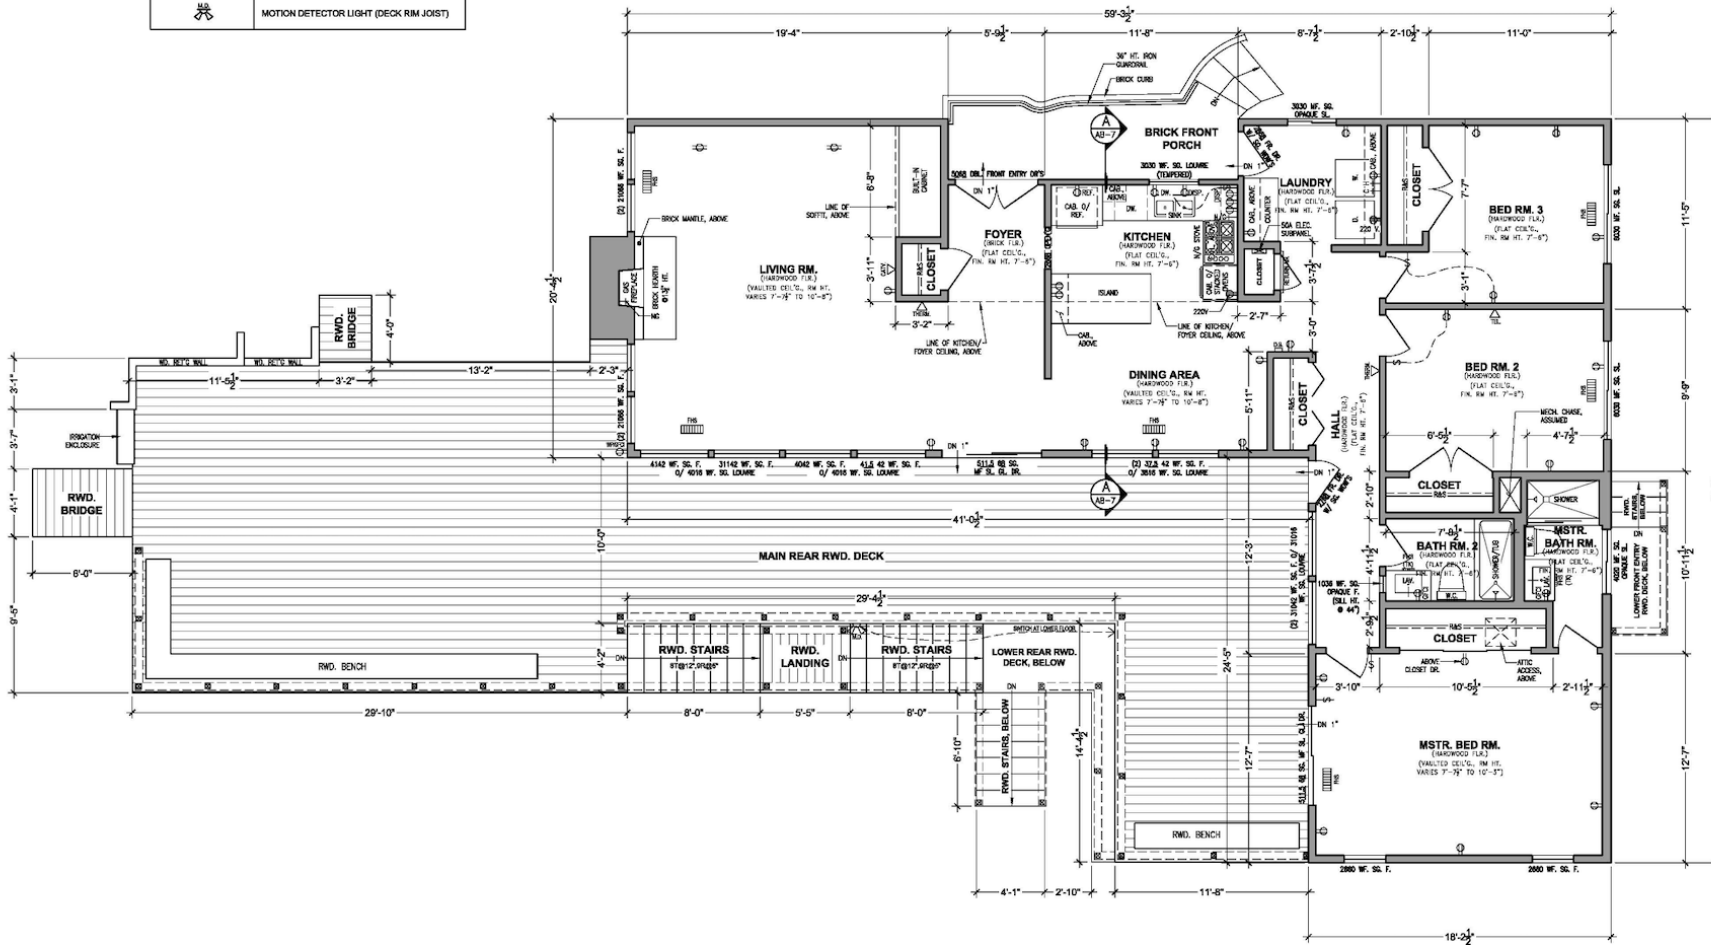

MAIN FLOOR PLAN

SCALE: 1/4"=1'-0"

REFERENCE - NOT FOR SUBMITTAL
ADDITIONAL COPIES AVAILABLE BY REQUEST